
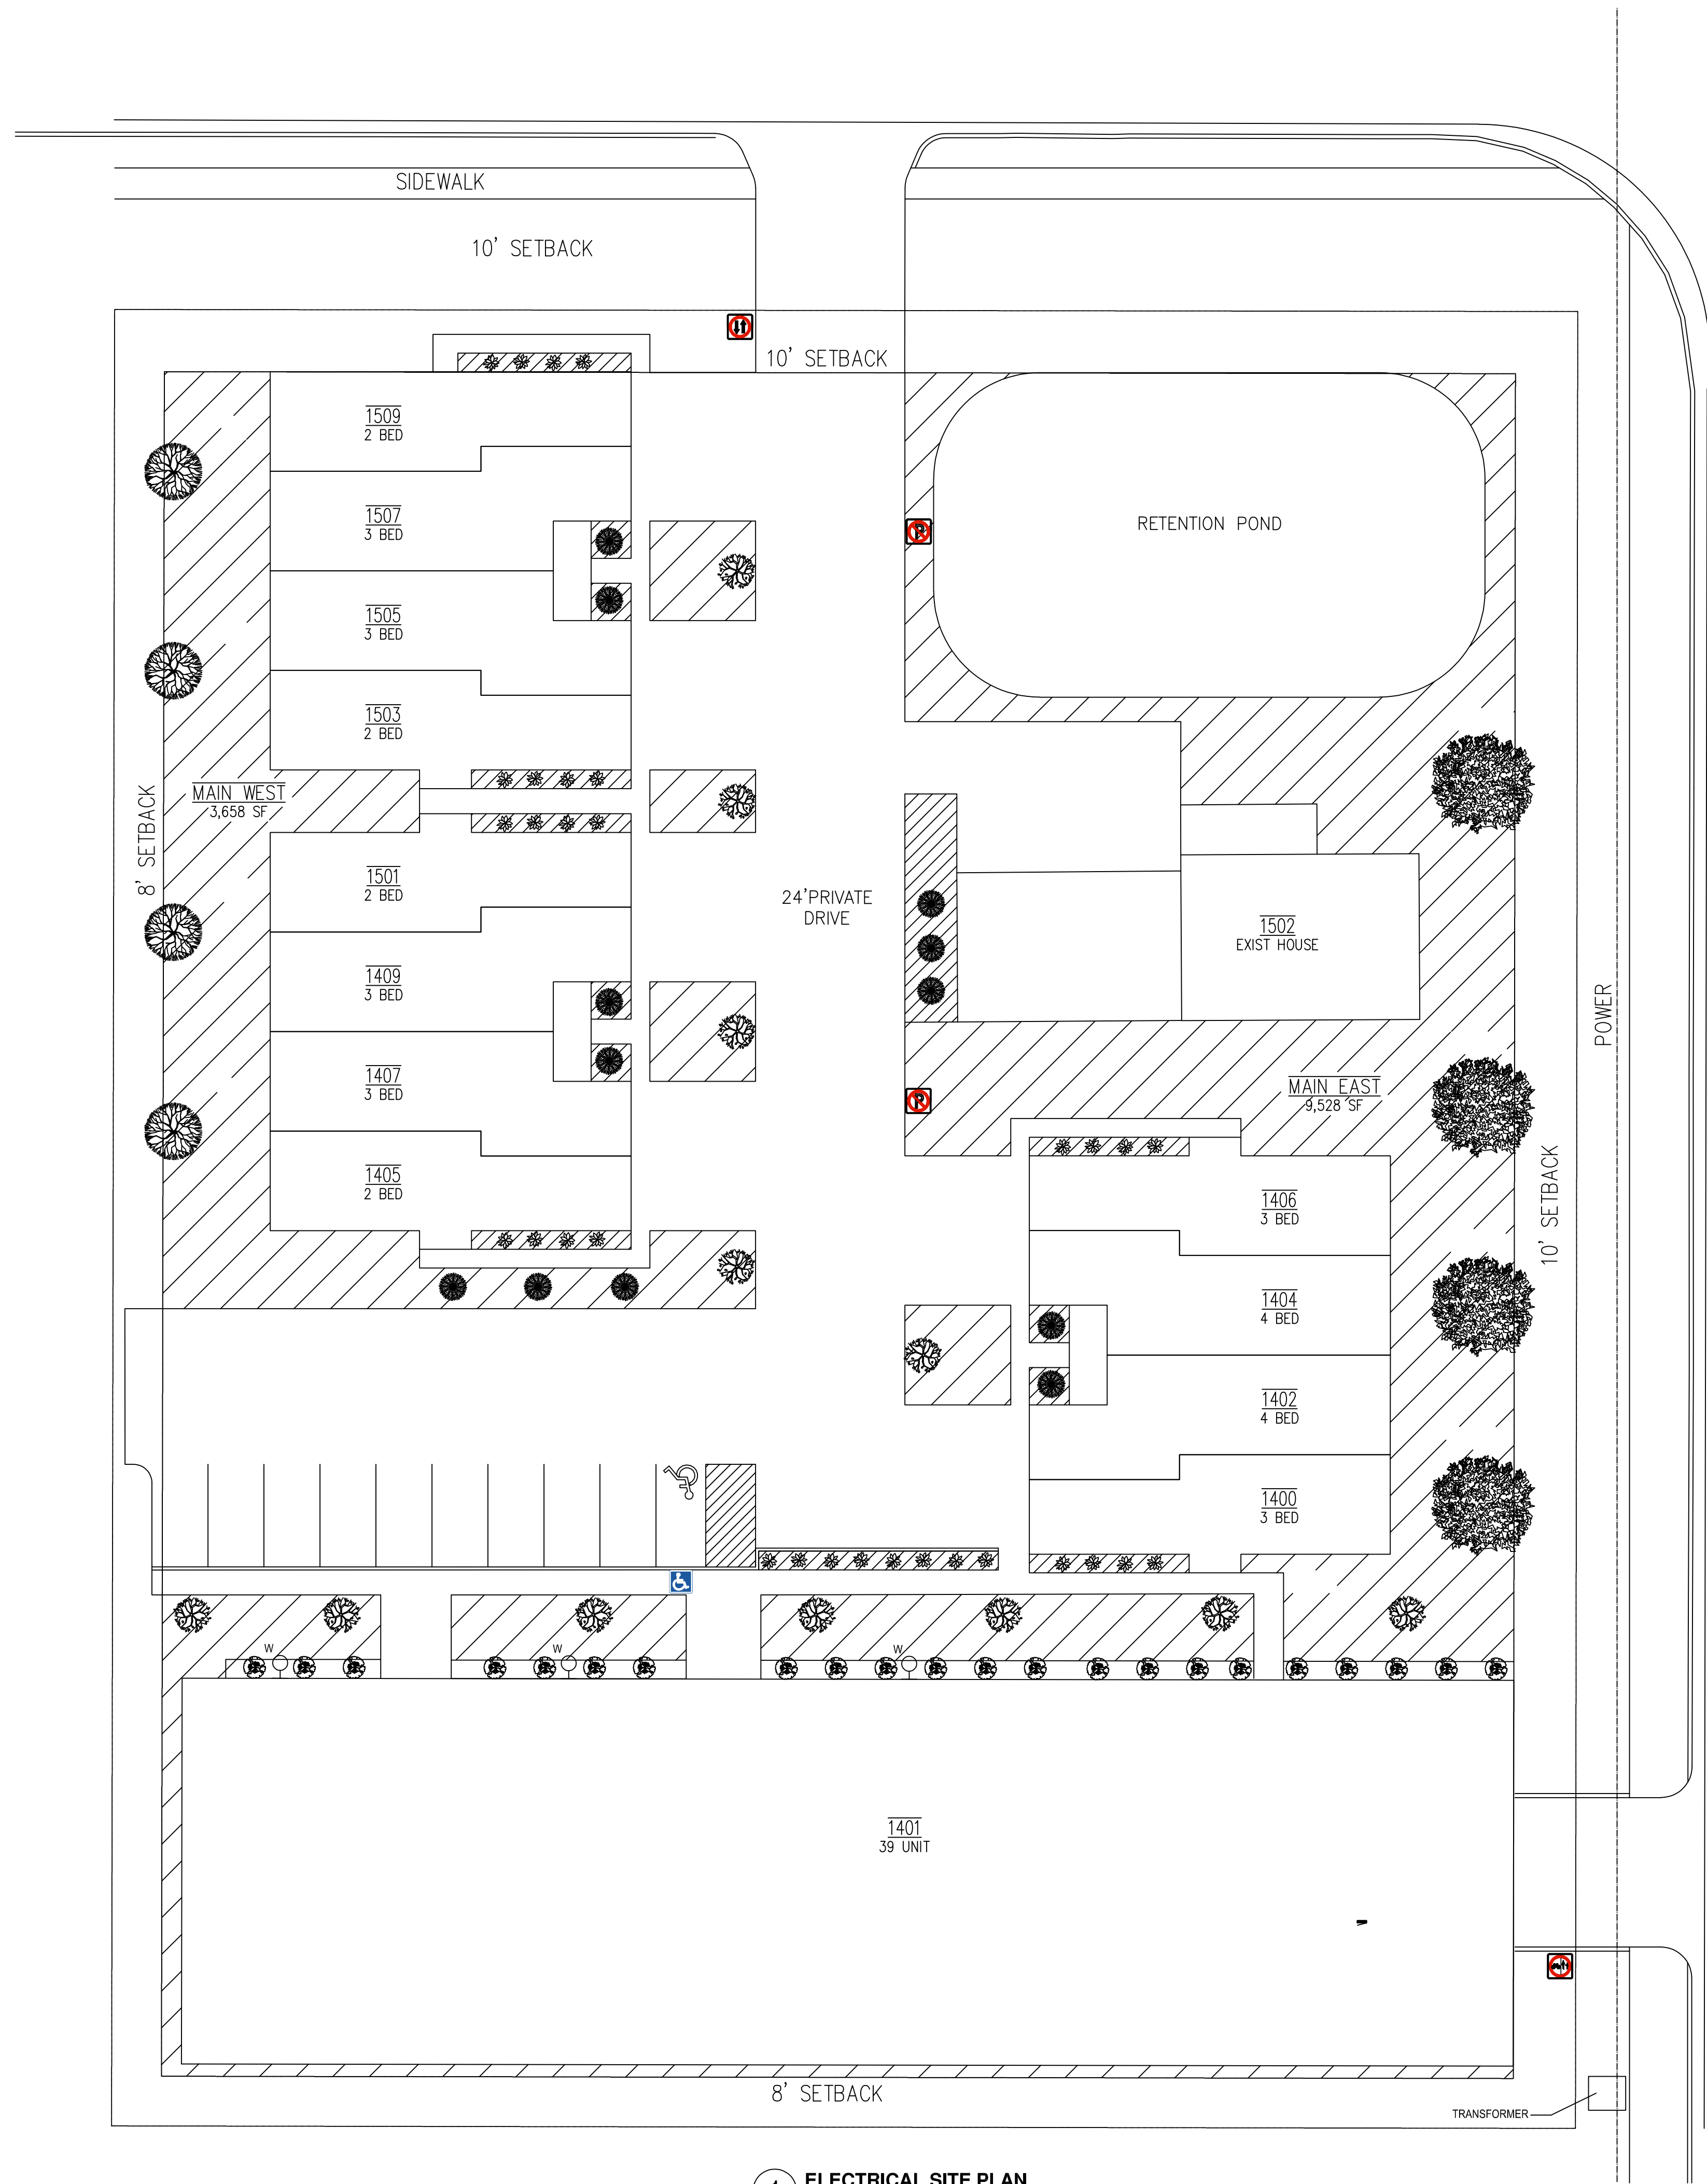


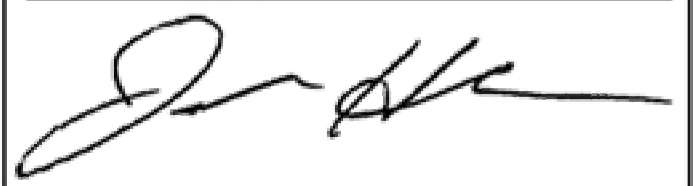

1 ELECTRICAL SITE PLAN
SCALE: 1/16" = 1'-0"

Accord Electric, Inc.
E000127


DATE: 8/4/2025


SHEET:

E1.0

4th Lane Flats

Kasson, MN 55944

Accord Electric, Inc.
E000127

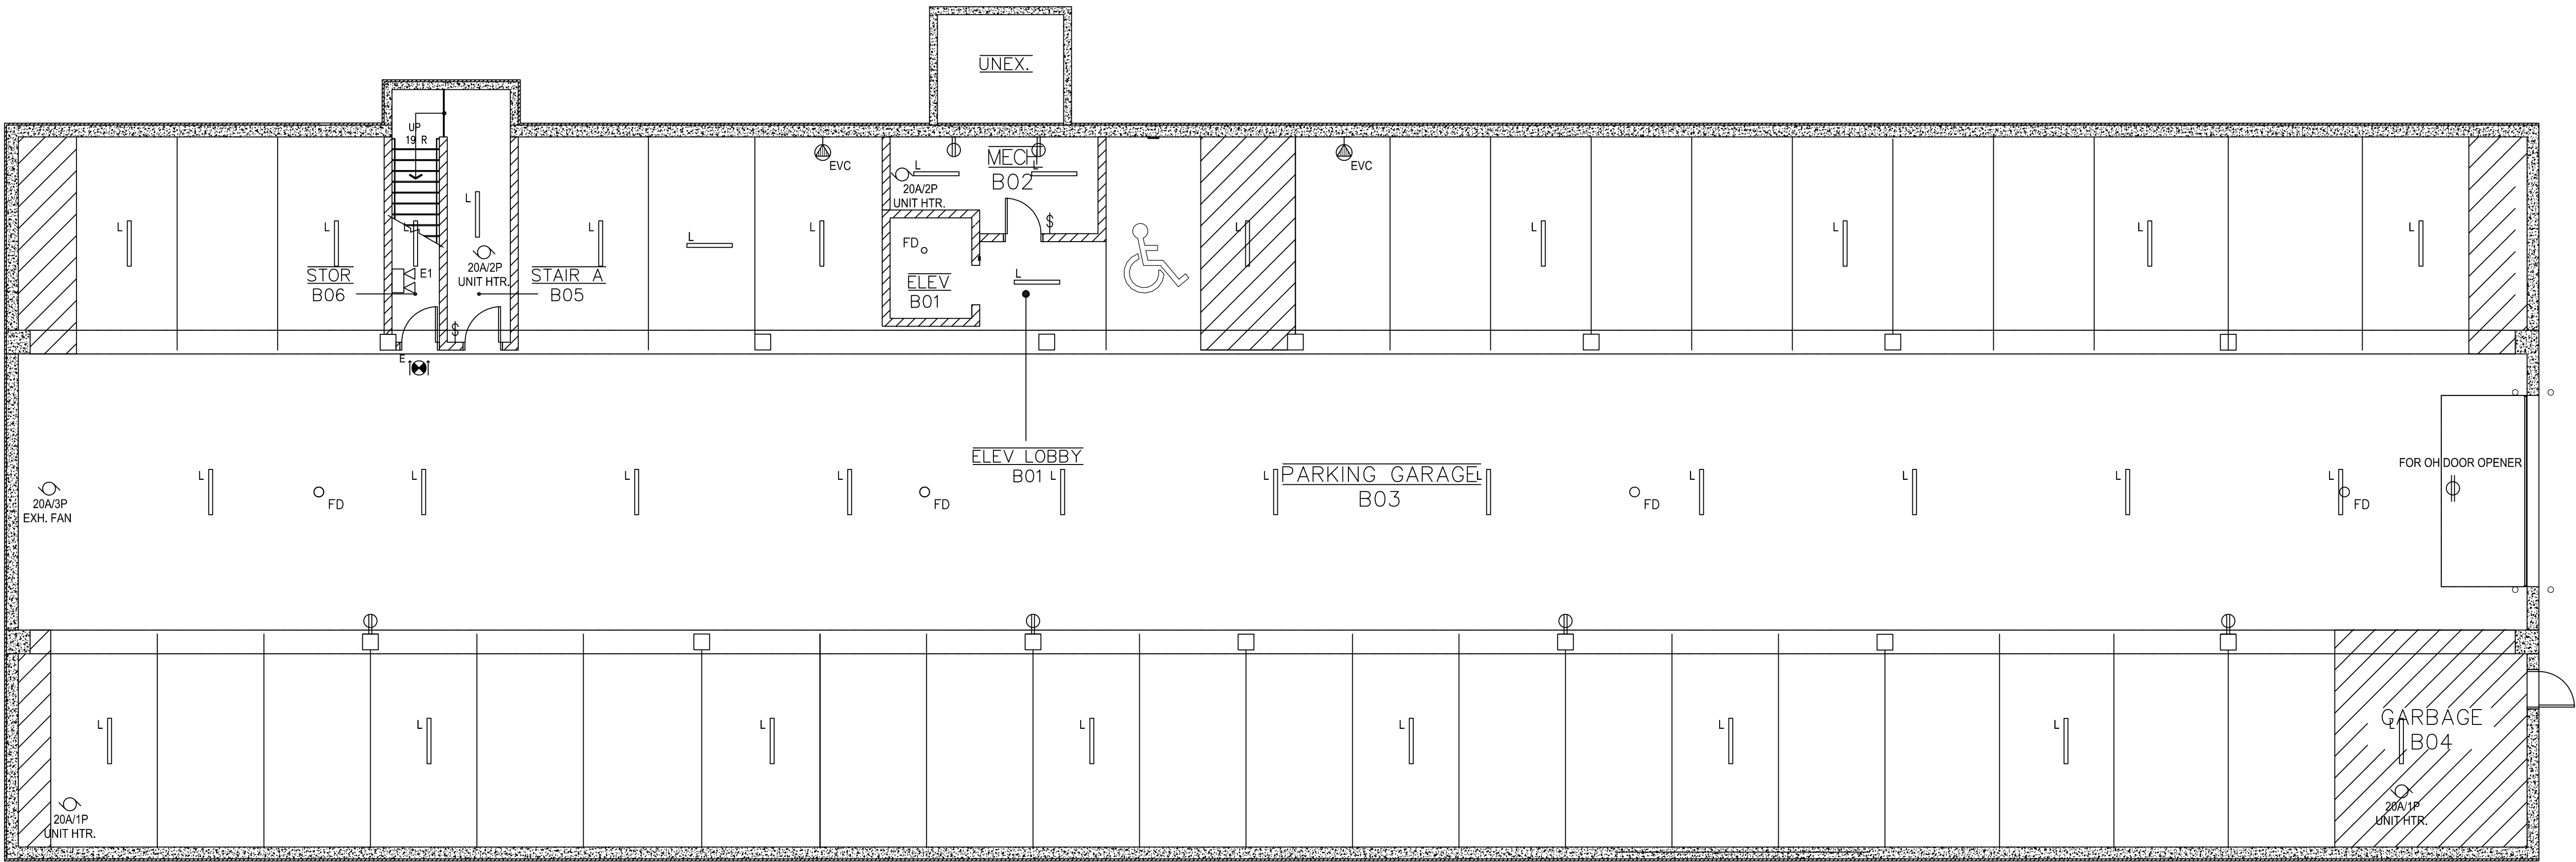



1 PARKING GARAGE ELECTRICAL PLAN
SCALE: 1/8" = 1'-0"

Accord Electric, Inc.
 E000127

[Signature]


SYMBOL KEY	
D	11" LED ROUND
D1	6" LED ROUND
E	LED EXIT SIGN
E1	LED EMERGENCY LIGHT
F	BATH VANITY LED LIGHT
H	LED CYLINDER LIGHT FIXTURE
SW	LIGHT SWITCH
3SW	3-WAY SWITCH
R	DUPLEX RECEPTACLE
R GFI	GFI DUPLEX RECEPTACLE
R S	SPECIAL RECEPTACLE
MC	MOTOR CONNECTION
EP	ELECTRICAL PANEL
EF	EXHAUST FAN
SD	SMOKE DETECTOR
SD CO	CARBON MONOXIDE SMOKE DETECTOR
TJ	TELEVISION JACK
DJ	DATA JACK

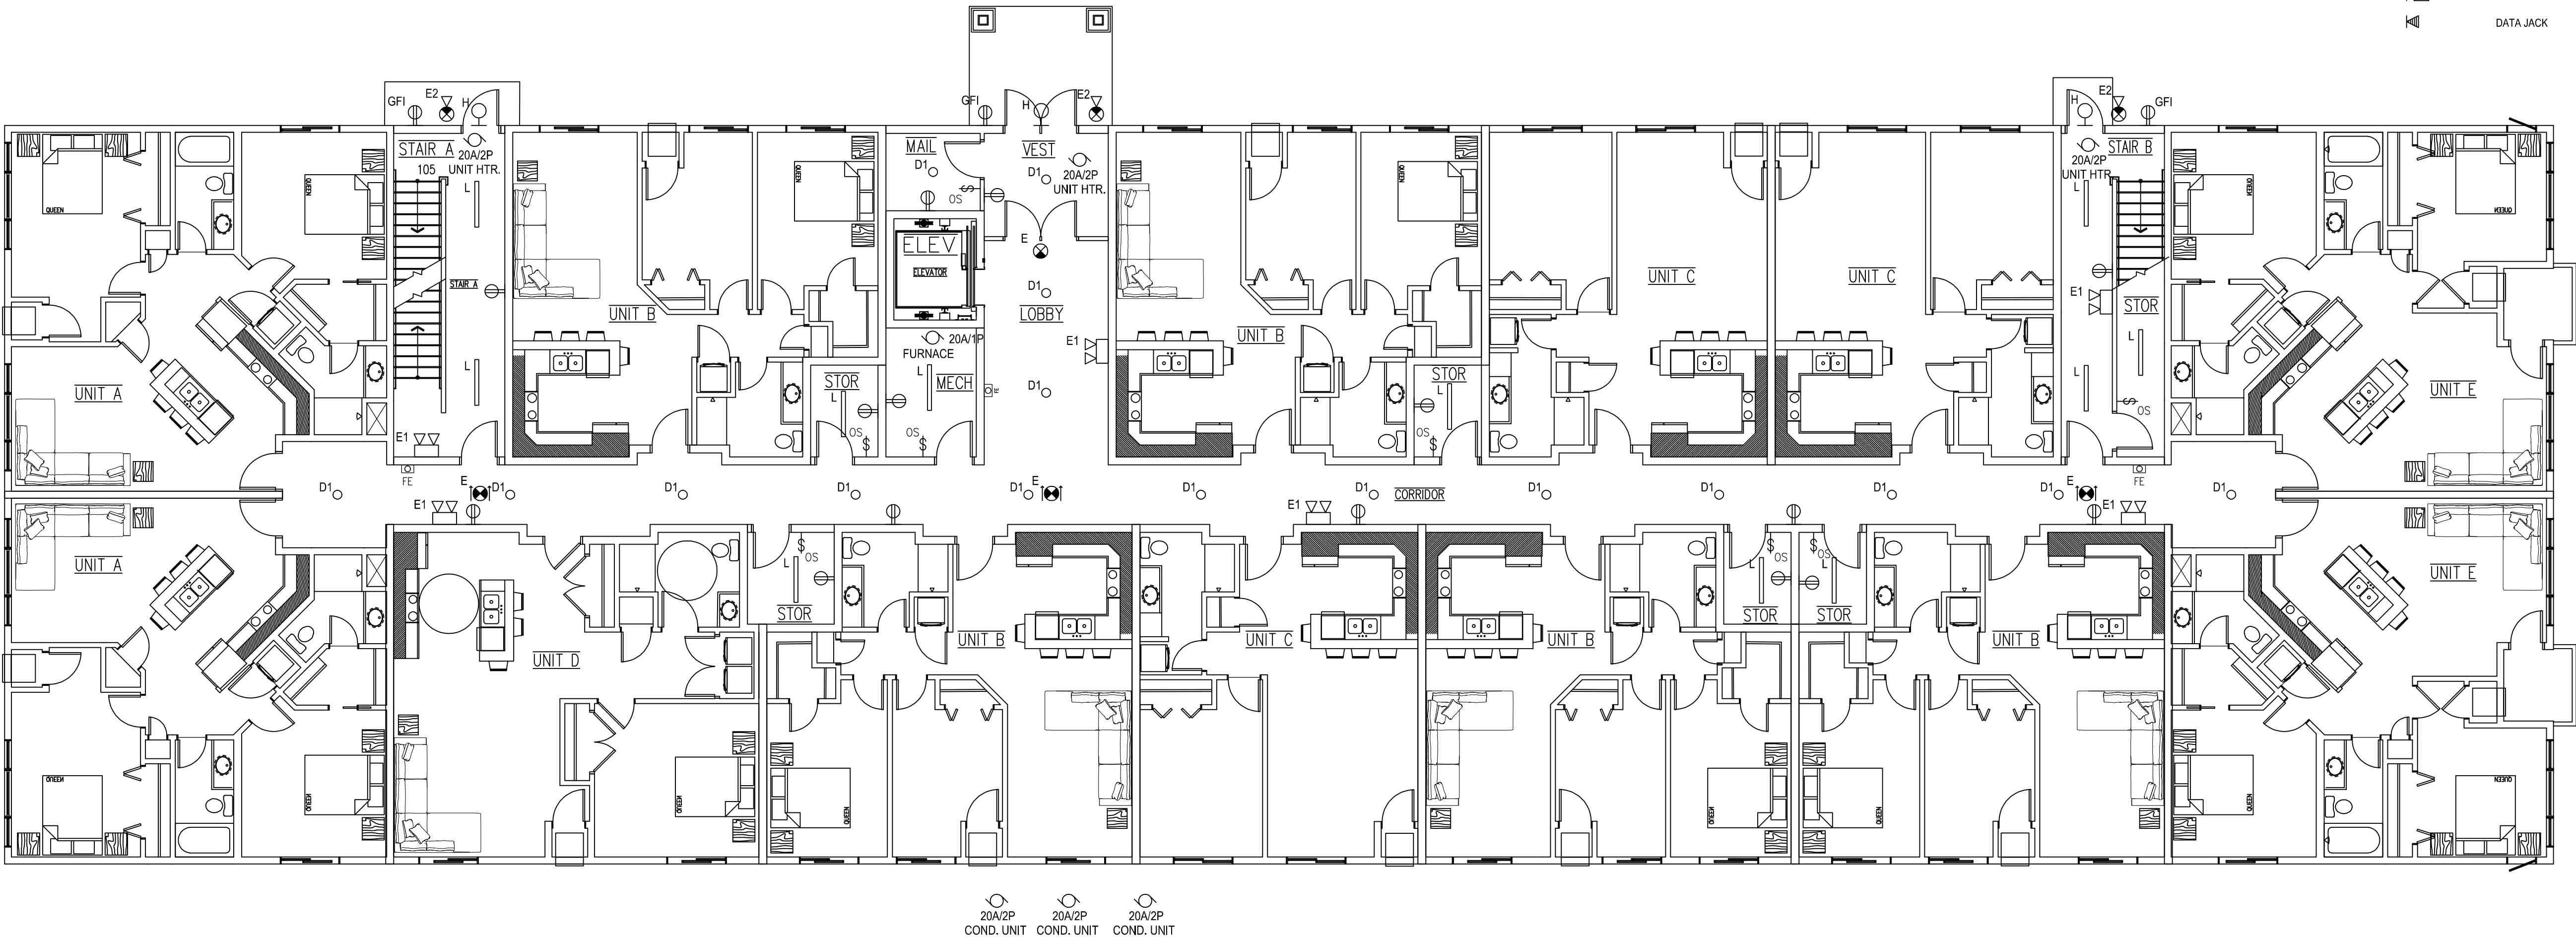

1 FIRST LEVEL ELECTRICAL PLAN
 SCALE: 1/8" = 1'-0"


SYMBOL KEY

D	○	11" LED ROUND
D1	○	6" LED ROUND
E	⬢	LED EXIT SIGN
E1	⬢	LED EMERGENCY LIGHT
F	○	BATH VANITY LED LIGHT
H	○	LED CYLINDER LIGHT FIXTURE
	⚡	LIGHT SWITCH
	⚡ 3	3-WAY SWITCH
	⚡	DUPLEX RECEPTACLE
	⚡ GFI	GFI DUPLEX RECEPTACLE
	⚡	SPECIAL RECEPTACLE
	⚡	MOTOR CONNECTION
	⬢	ELECTRICAL PANEL
	⬢	EXHAUST FAN
	⬢	SMOKE DETECTOR
	⬢ CO	CARBON MONOXIDE SMOKE DETECTOR
	⬢ TV	TELEVISION JACK
	⬢	DATA JACK

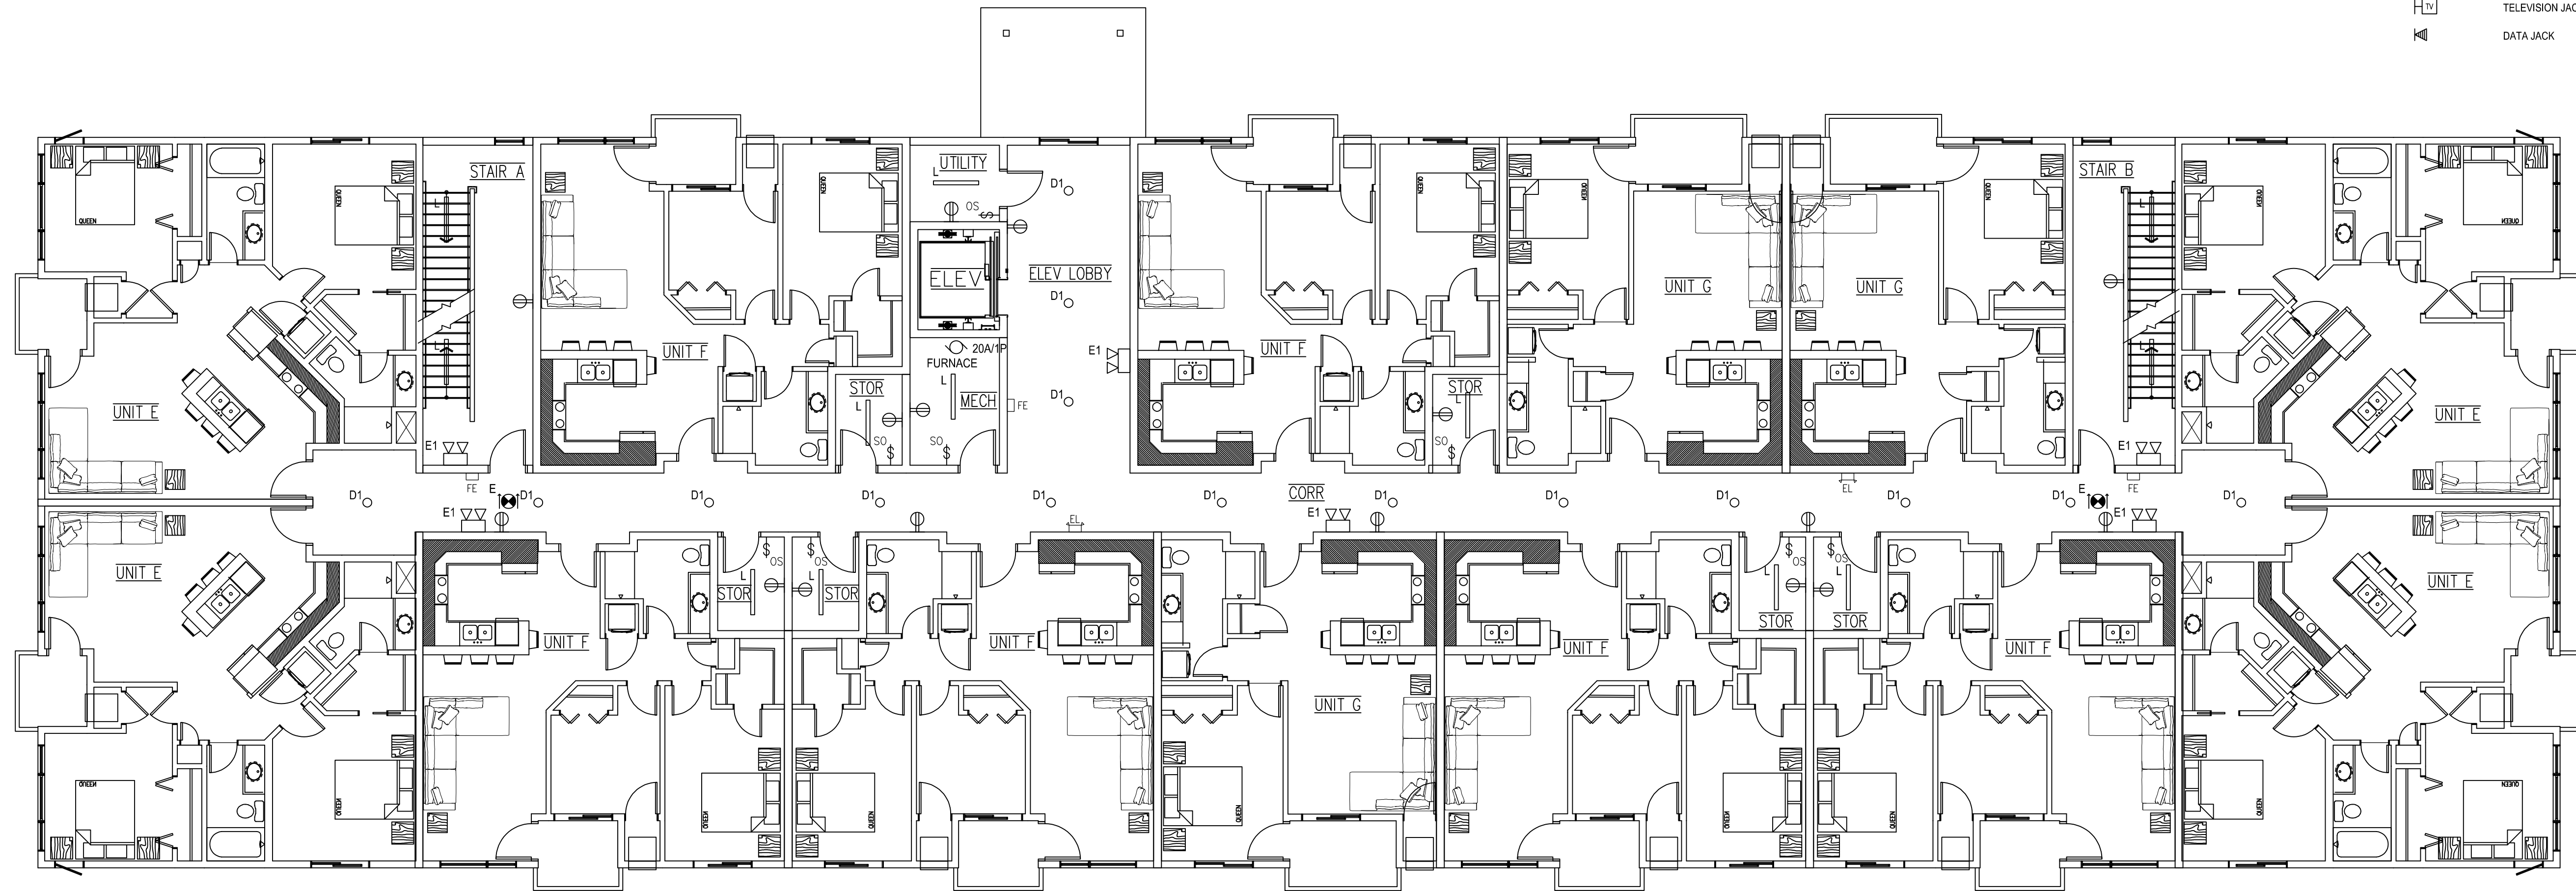


Accord Electric, Inc.
 E000127



SYMBOL KEY	
D	11" LED ROUND
D1	6" LED ROUND
E	LED EXIT SIGN
E1	LED EMERGENCY LIGHT
F	BATH VANITY LED LIGHT
H	LED CYLINDER LIGHT FIXTURE
	LIGHT SWITCH
3	3-WAY SWITCH
	DUPLEX RECEPTACLE
GFI	GFI DUPLEX RECEPTACLE
	SPECIAL RECEPTACLE
	MOTOR CONNECTION
	ELECTRICAL PANEL
EF	EXHAUST FAN
SD	SMOKE DETECTOR
CO	CARBON MONOXIDE SMOKE DETECTOR
TJ	TELEVISION JACK
	DATA JACK

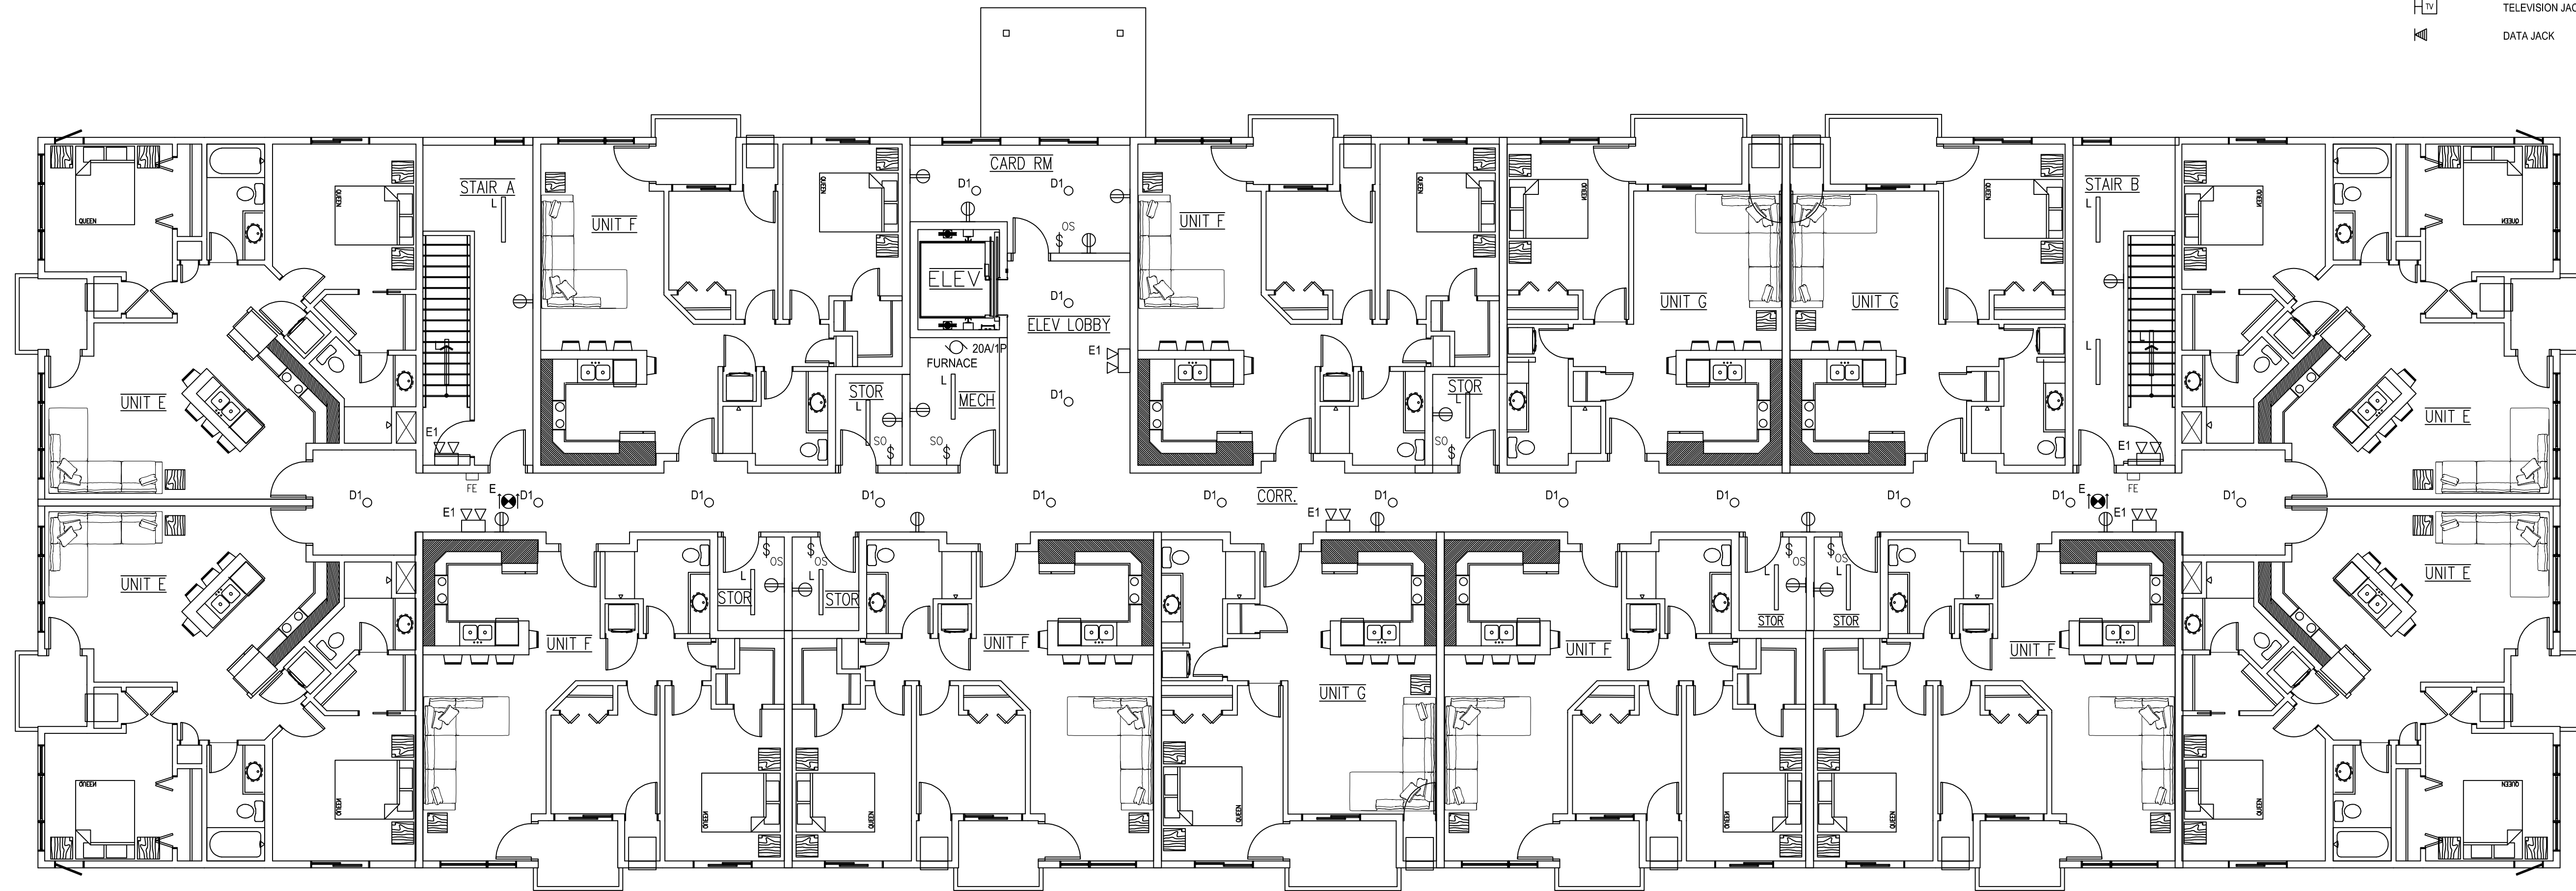


Accord Electric, Inc.
E000127

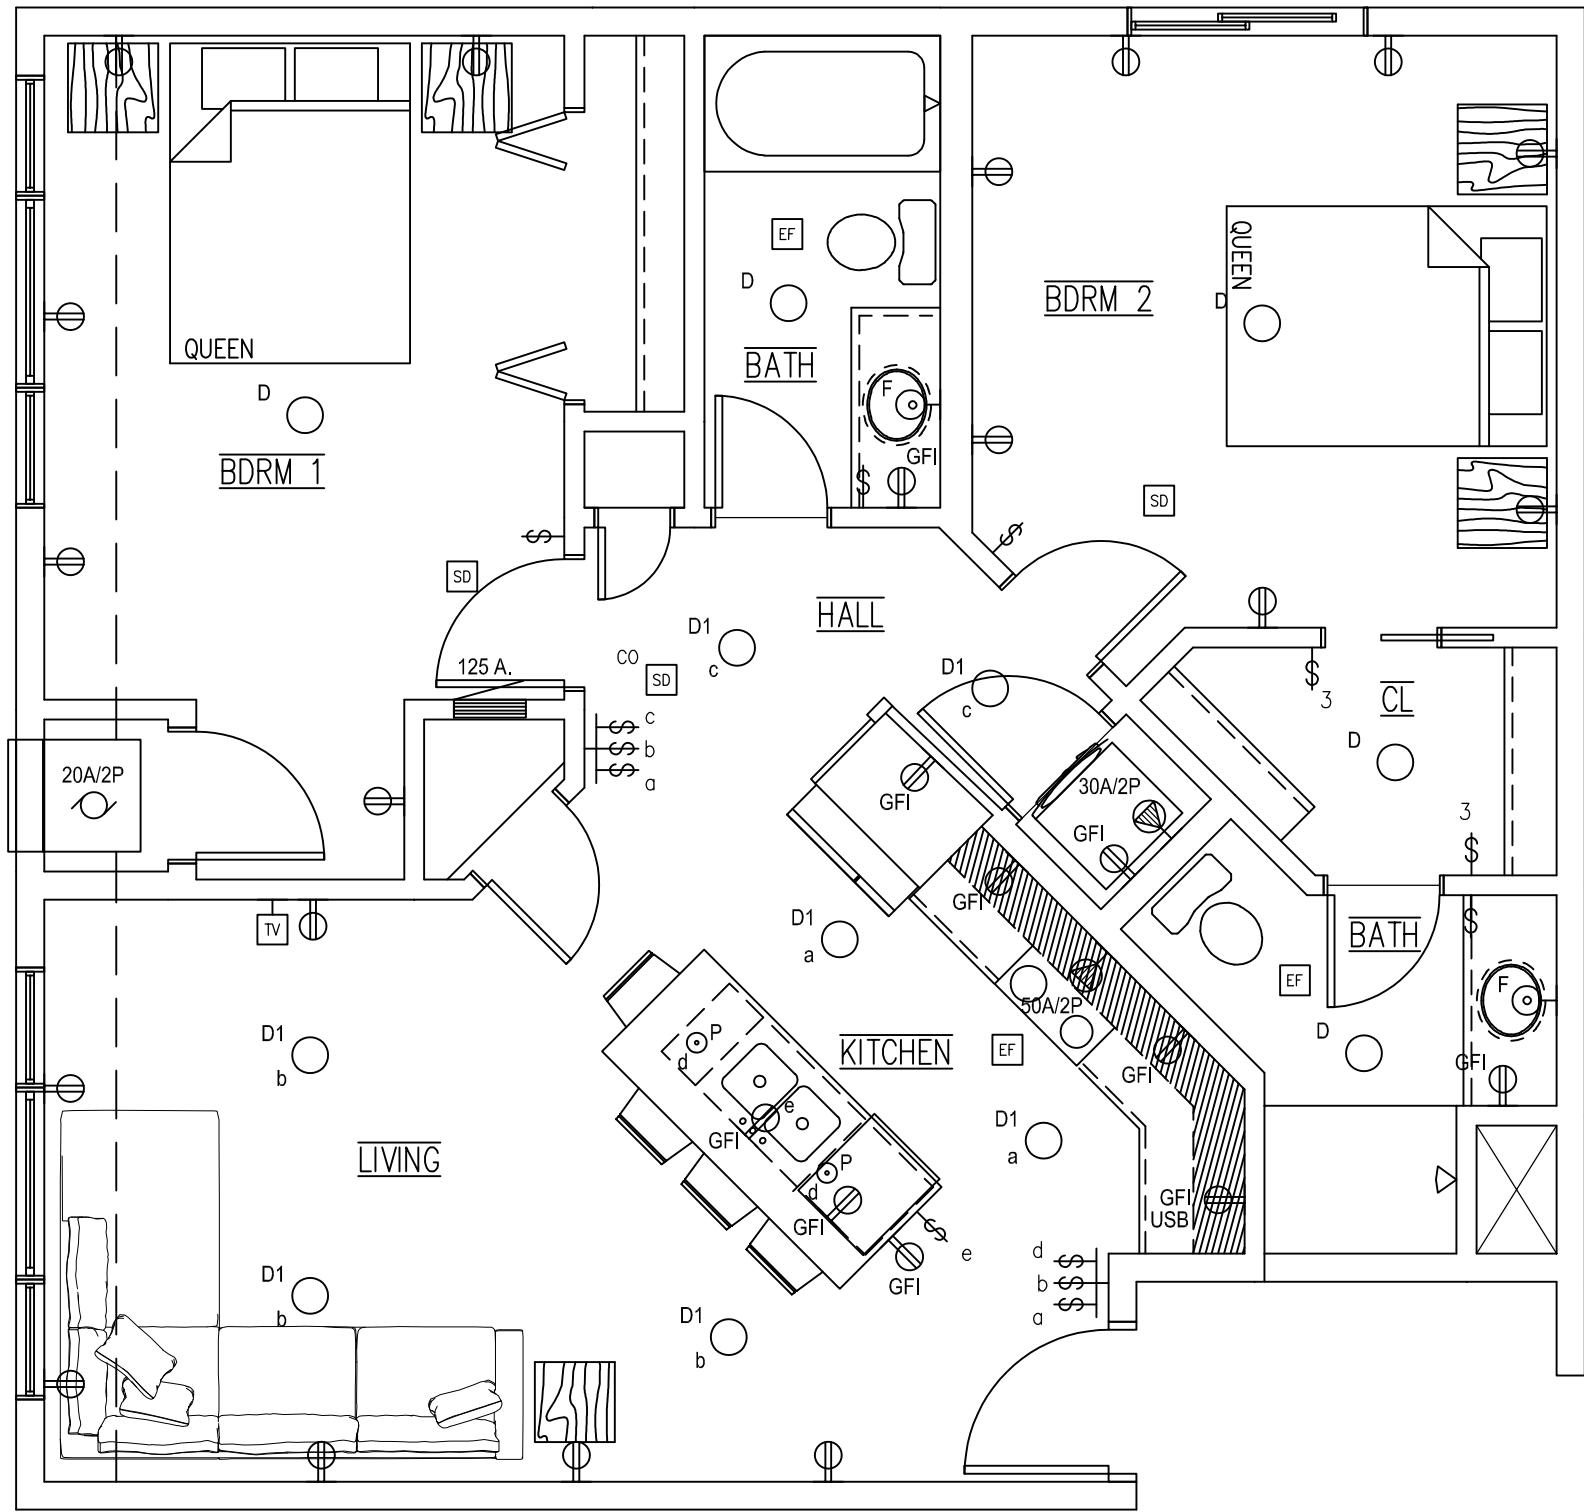


1 UNIT A TYPICAL ELECTRICAL PLAN
SCALE: 1/4" = 1'-0"

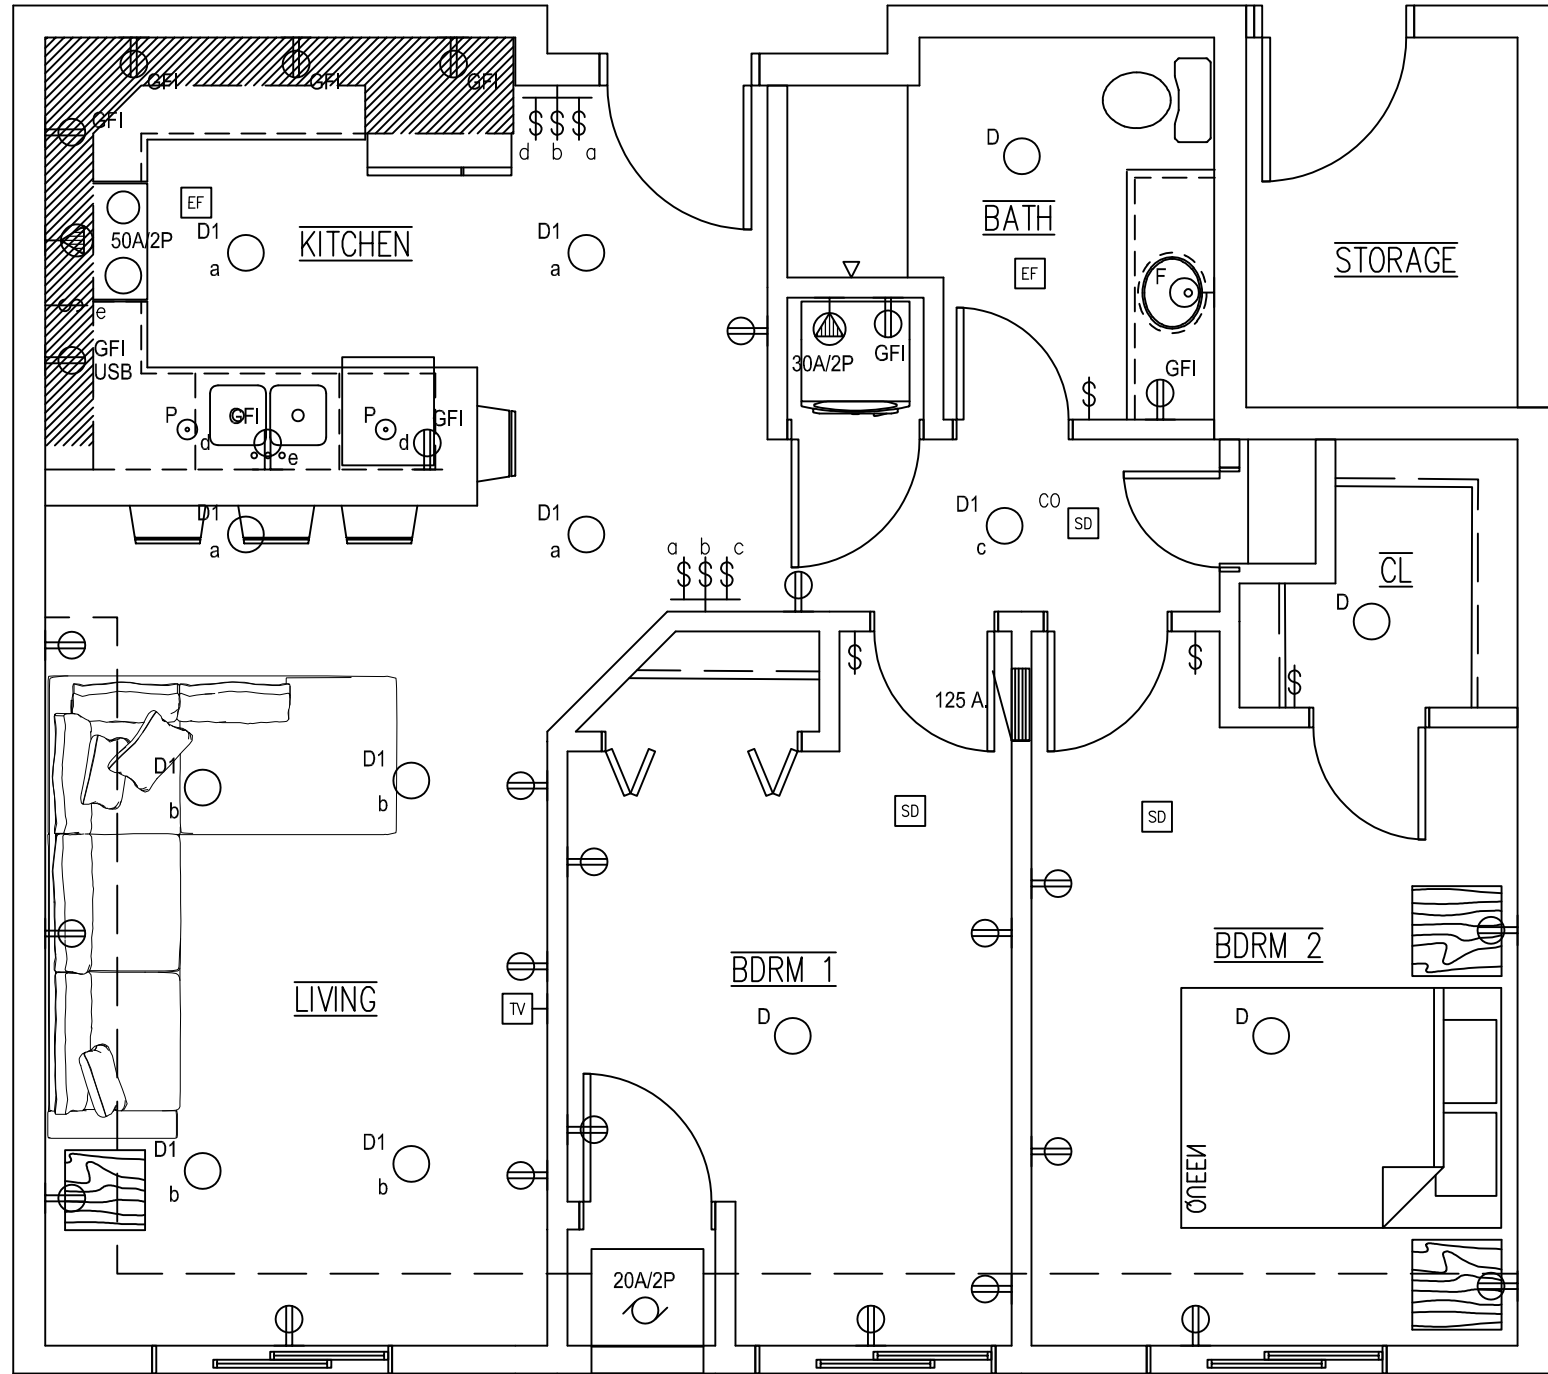

2 UNIT B TYPICAL ELECTRICAL PLAN
SCALE: 1/4" = 1'-0"

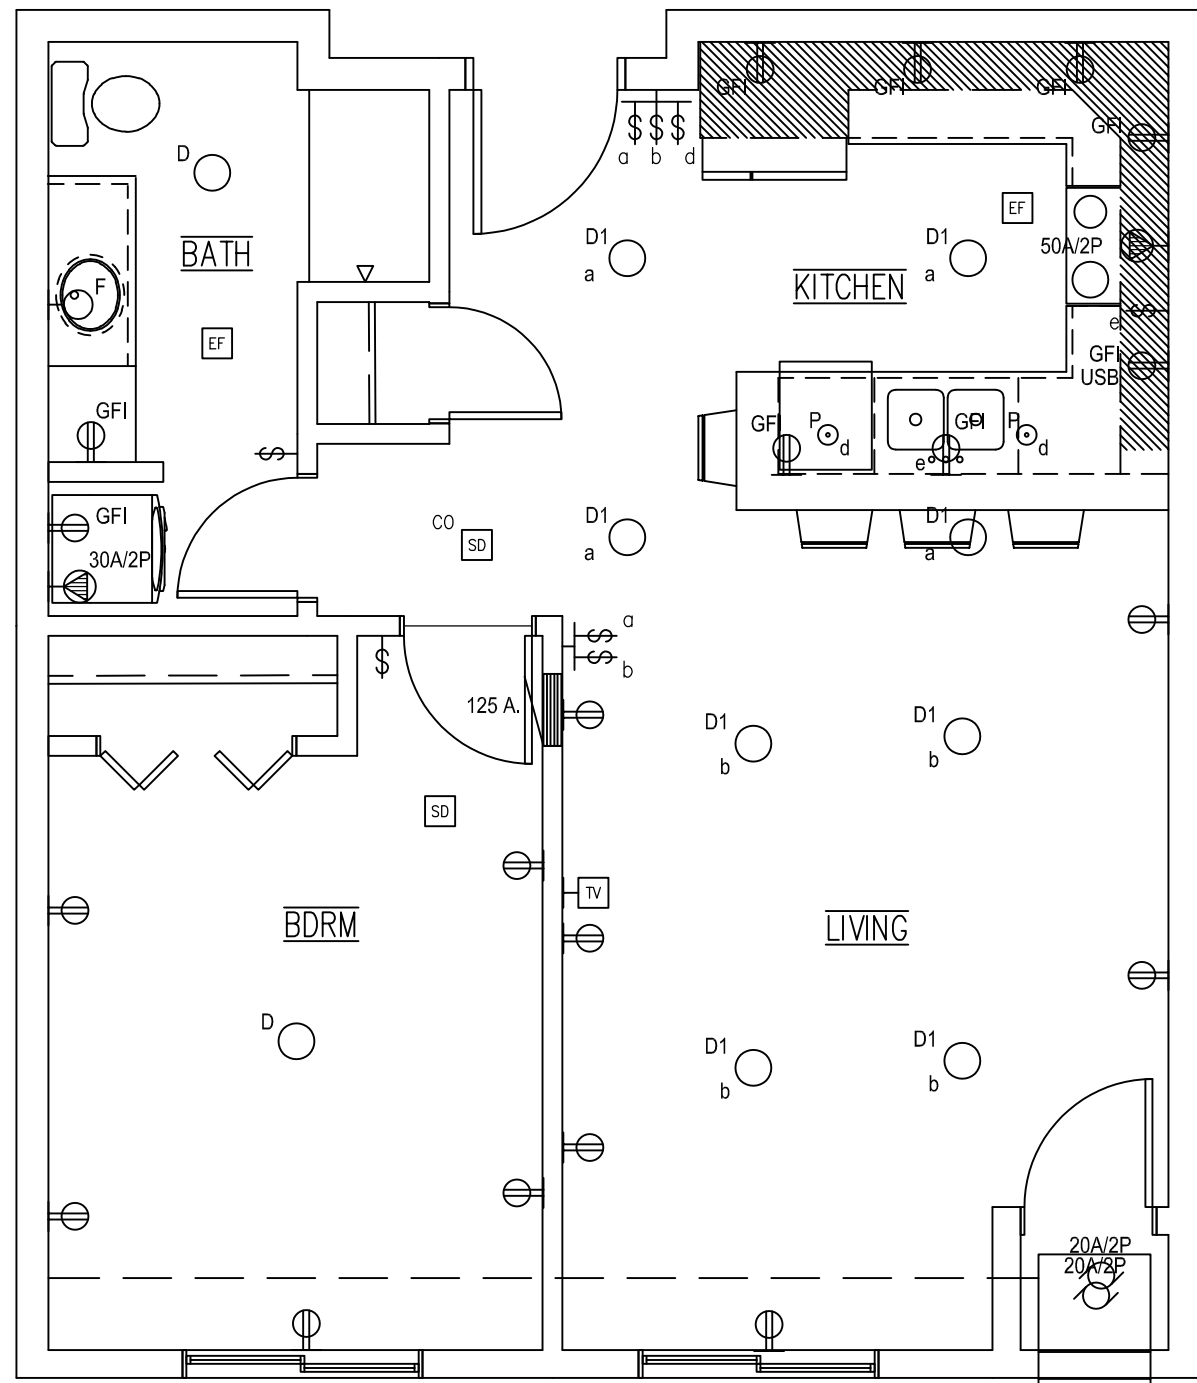

3 UNIT C TYPICAL ELECTRICAL PLAN
SCALE: 1/4" = 1'-0"

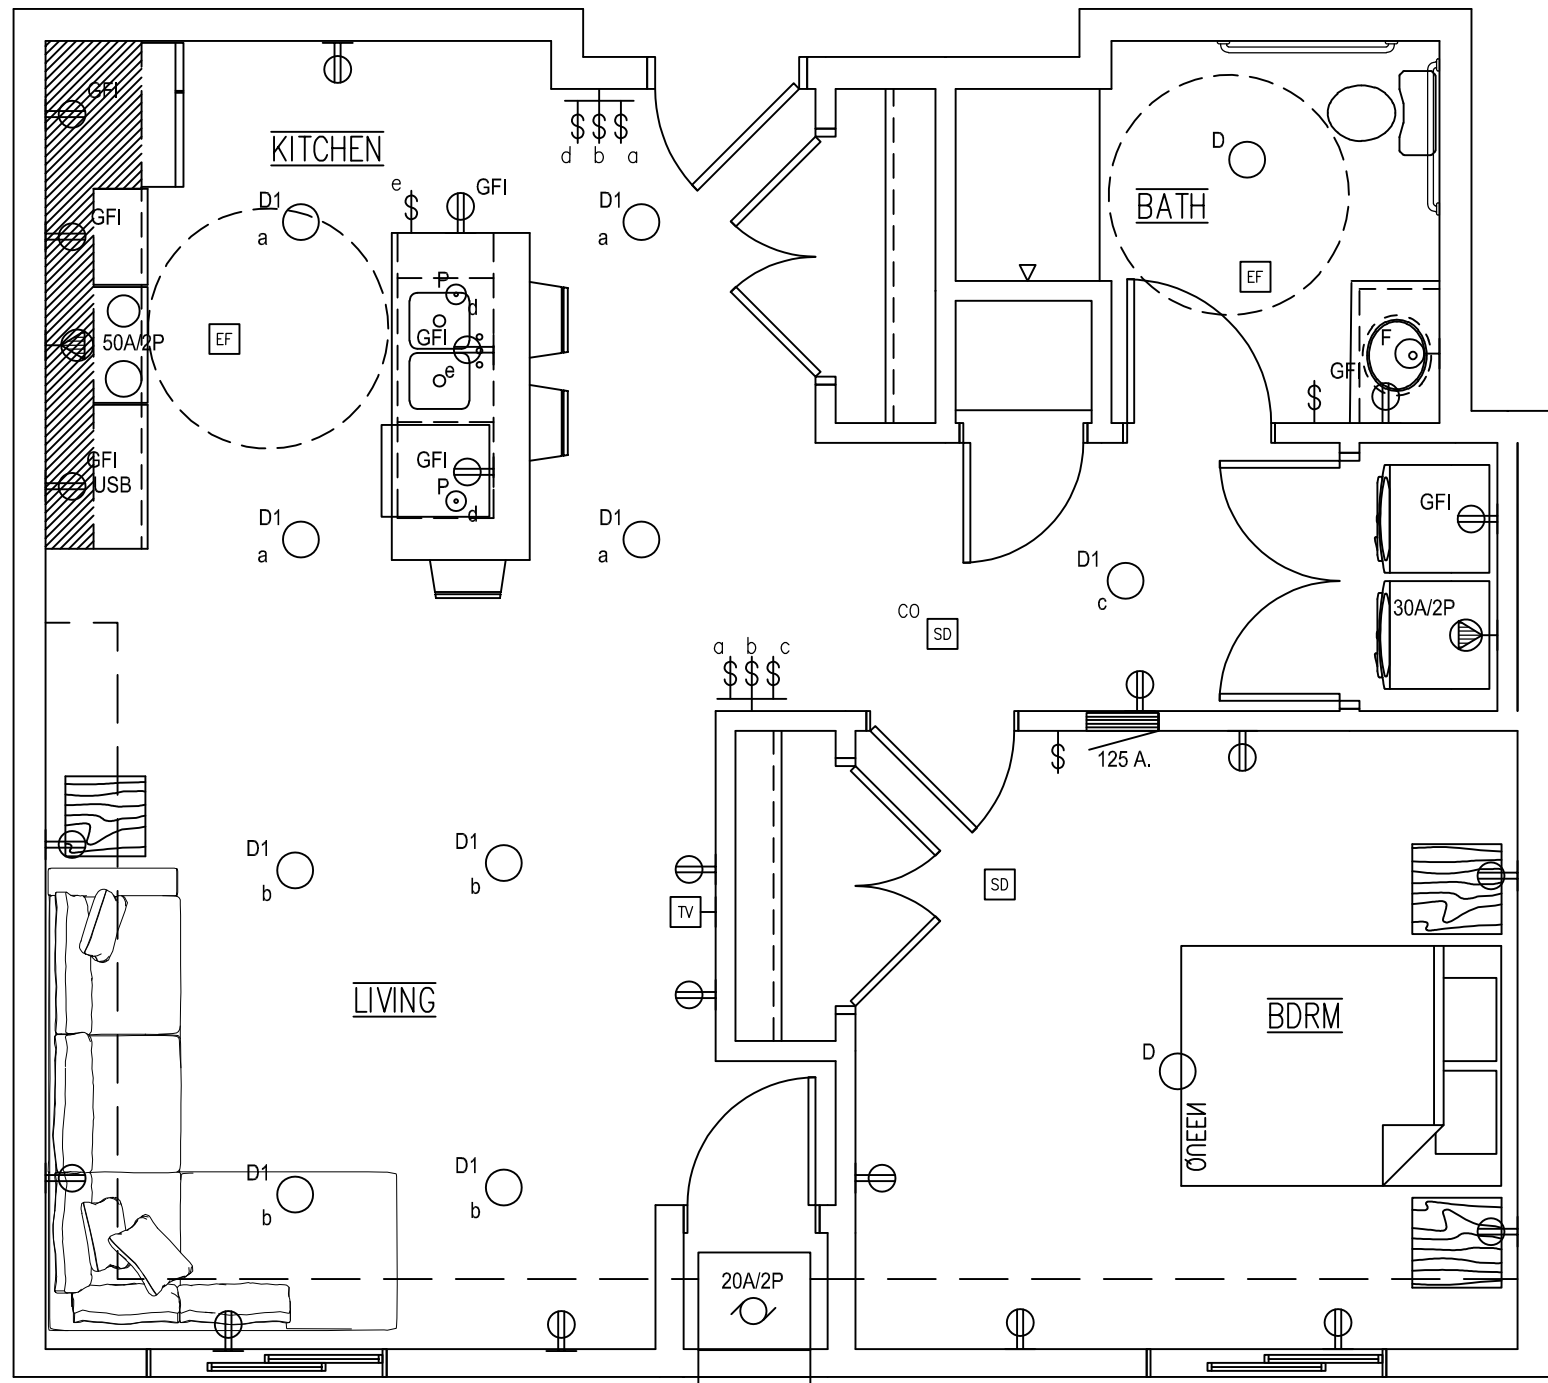


4 UNIT D TYPICAL ELECTRICAL PLAN
SCALE: 1/4" = 1'-0"


SYMBOL KEY	
	11" LED ROUND
	6" LED ROUND
	BATH VANITY LED LIGHT
	LED CYLINDER LIGHT FIXTURE
	LIGHT SWITCH
	3-WAY SWITCH
	DUPLEX RECEPTACLE
	GFI DUPLEX RECEPTACLE
	SPECIAL RECEPTACLE
	MOTOR CONNECTION
	ELECTRICAL PANEL
	EXHAUST FAN
	SMOKE DETECTOR
	CARBON MONOXIDE SMOKE DETECTOR
	TELEVISION JACK
	DATA JACK

SYMBOL KEY


D	11" LED ROUND
D1	6" LED ROUND
F	BATH VANITY LED LIGHT
H	LED CYLINDER LIGHT FIXTURE
⚡	LIGHT SWITCH
⚡ 3	3-WAY SWITCH
⌚	DUPLEX RECEPTACLE
⌚ GFI	GFI DUPLEX RECEPTACLE
⌚	SPECIAL RECEPTACLE
⚡	MOTOR CONNECTION
⌚	ELECTRICAL PANEL
EF	EXHAUST FAN
SD	SMOKE DETECTOR
SD CO	CARBON MONOXIDE SMOKE DETECTOR
TV	TELEVISION JACK
⌚	DATA JACK

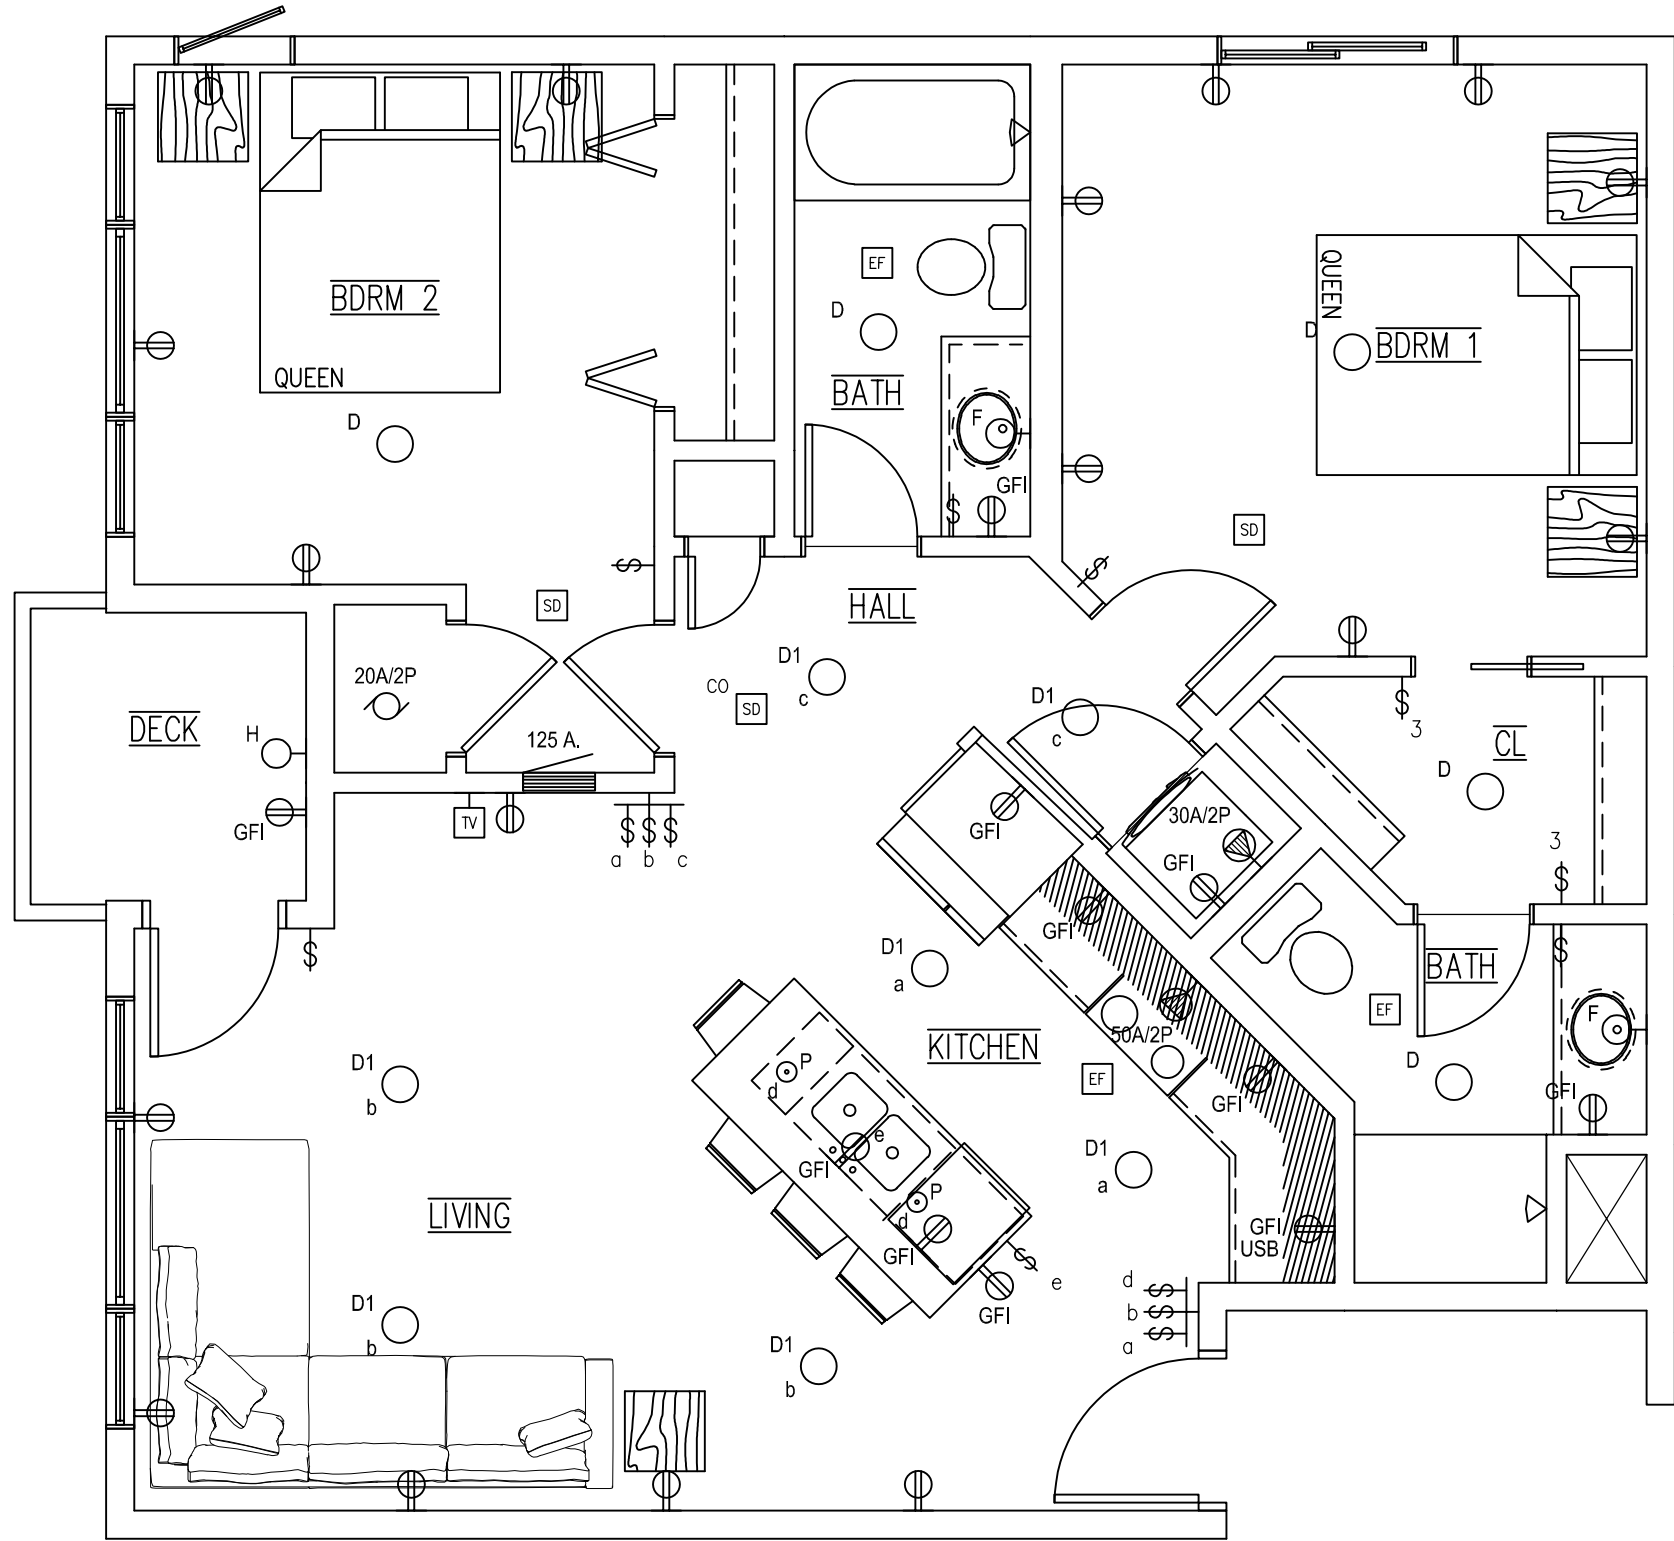

1 UNIT E TYPICAL ELECTRICAL PLAN
SCALE: 1/4" = 1'-0"

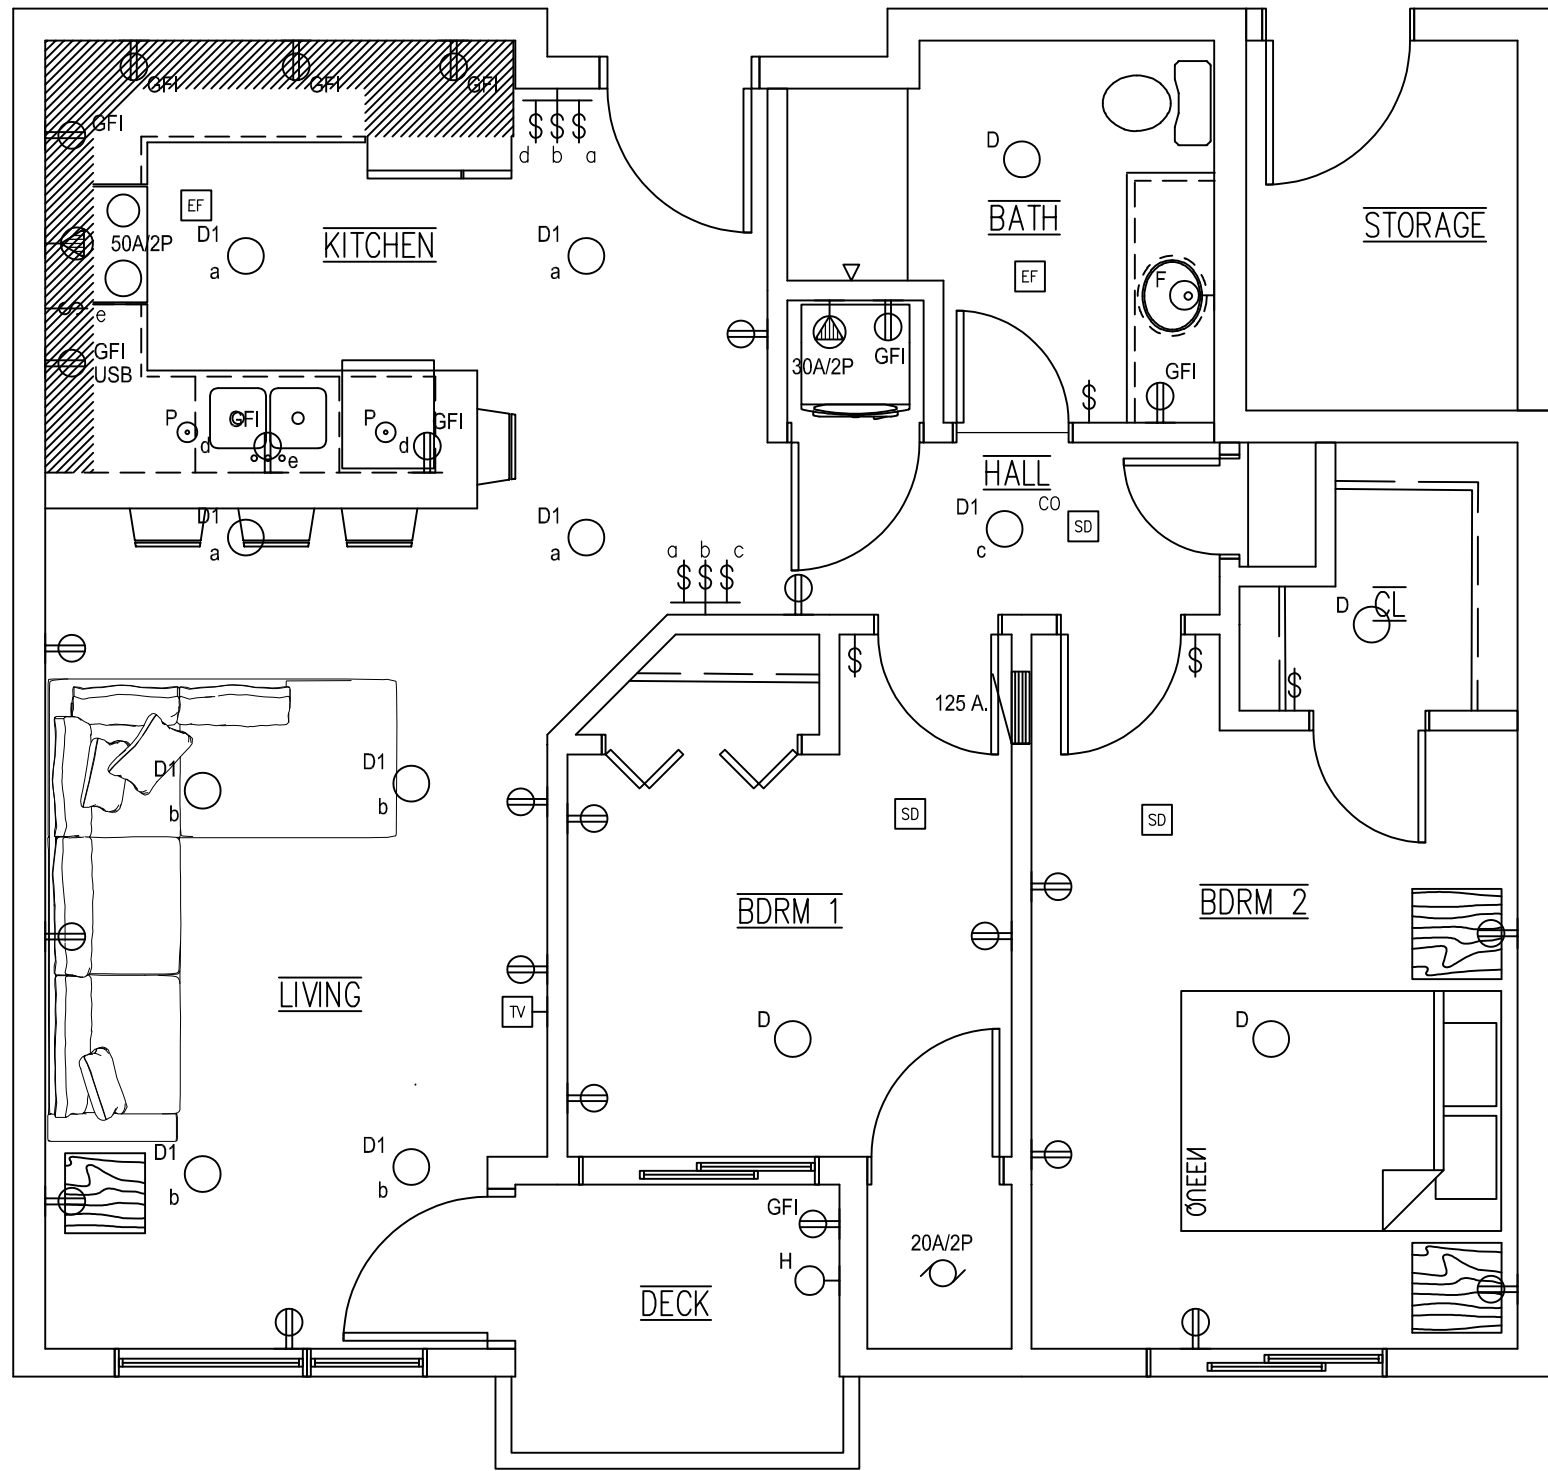


2 UNIT F TYPICAL ELECTRICAL PLAN
SCALE: 1/4" = 1'-0"

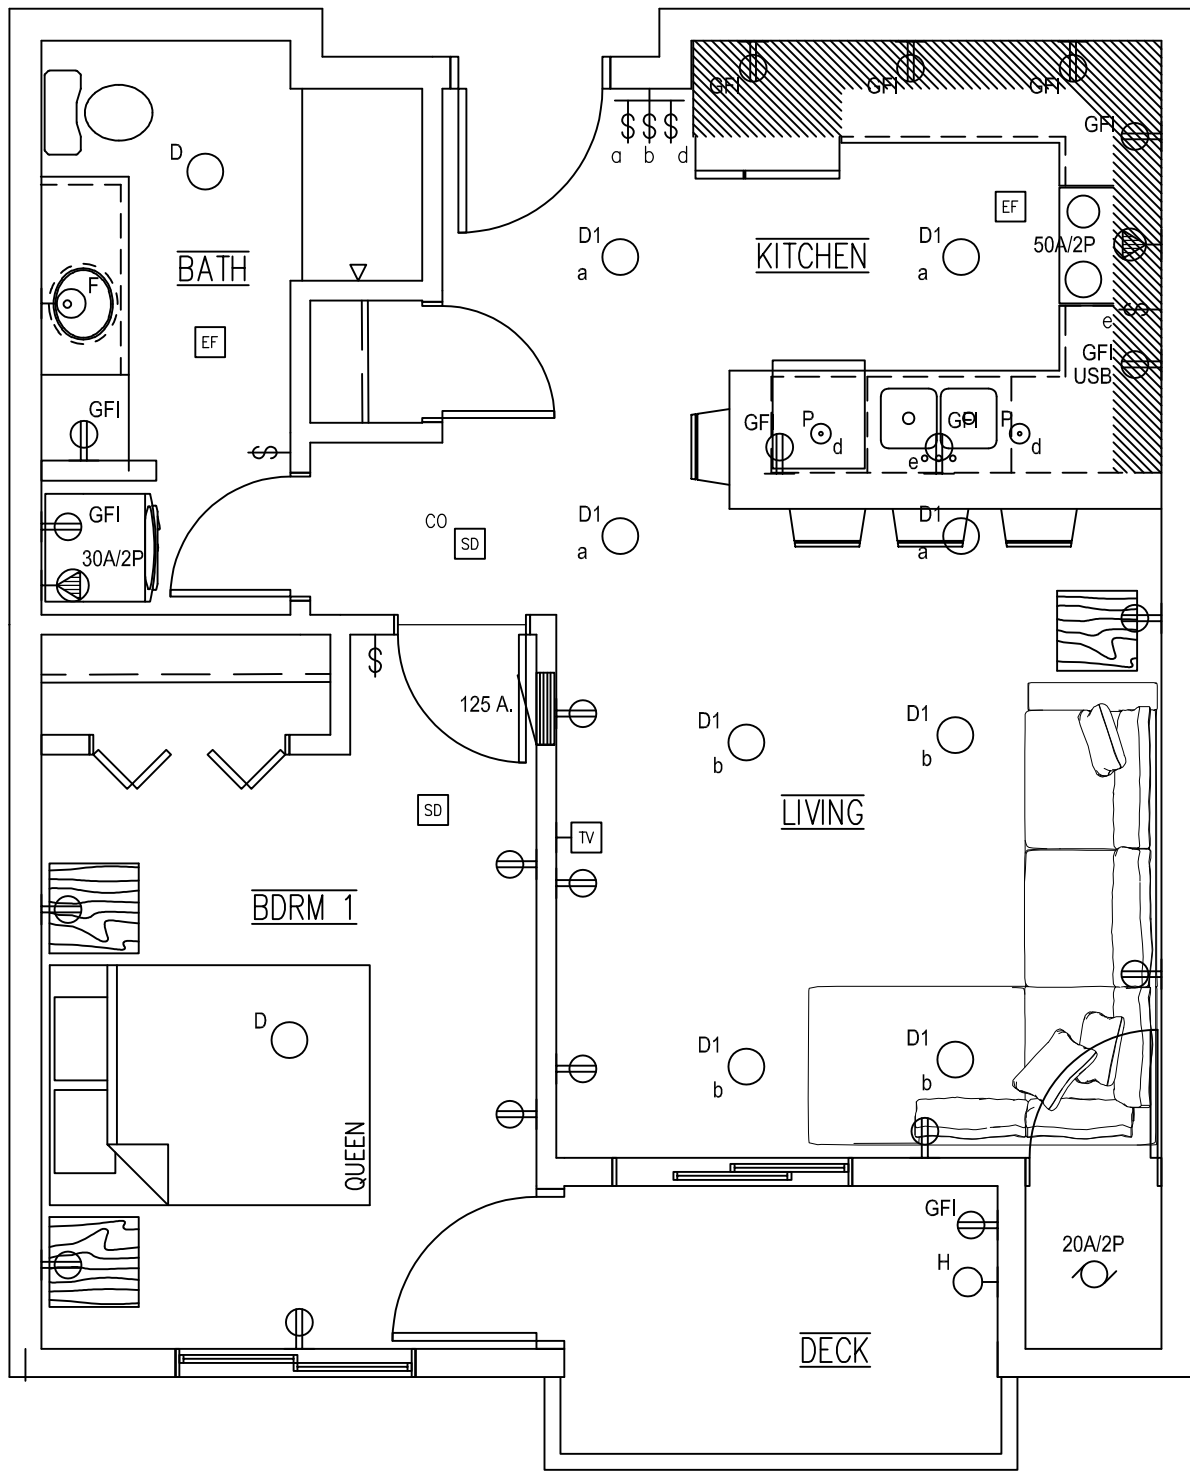

3 UNIT G TYPICAL ELECTRICAL PLAN
SCALE: 1/4" = 1'-0"

Accord Electric, Inc.
E000127

[Signature]

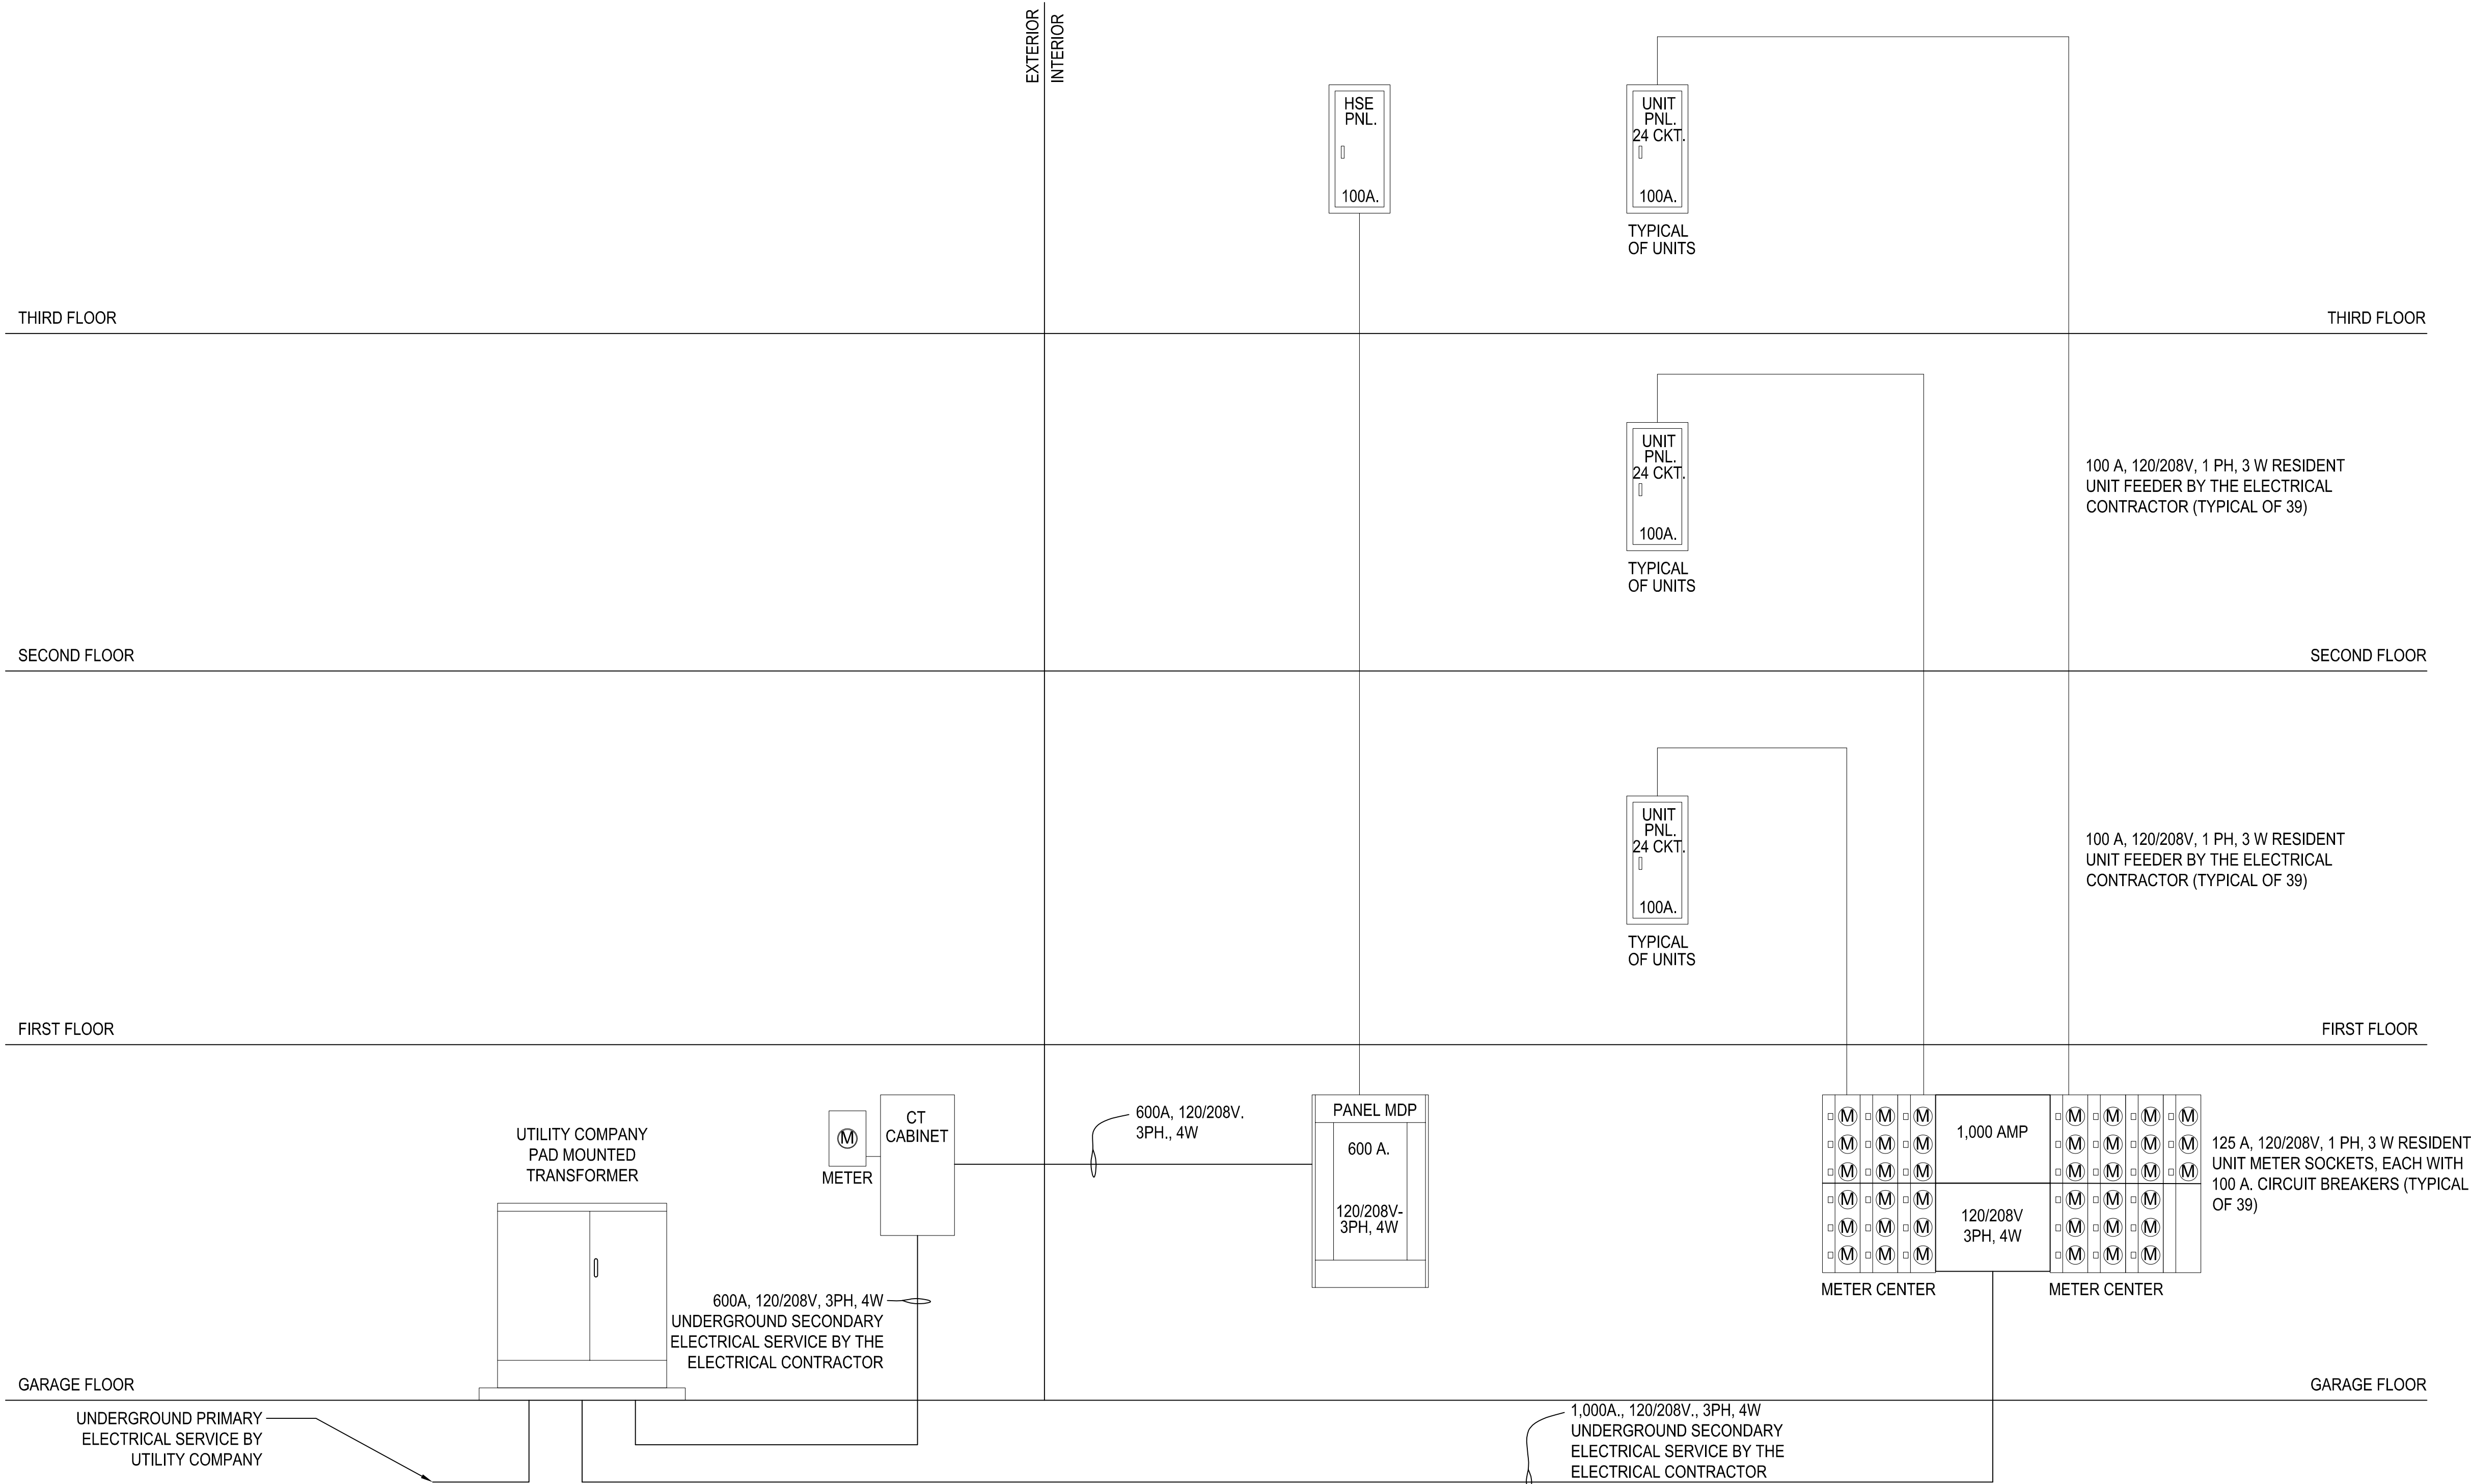

1 ELECTRICAL RISER DIAGRAM
SCALE: N.T.S.

PANEL: TYPICAL UNIT PANEL						CKT. BRKR. AIC: 10,000	
LOCATION: UNITS						MTG: Recessed	
VOLTAGE: 120/208 Volt, 1 Phs, 3 Wire						BUS: 100 Amp Bus MLO	
CIRCUIT DESCRIPTION	CIRCUIT BRKR	NO.	PHASE A	PHASE B	PHASE C	CIRCUIT NO.	BRKR
SMALL APPLIANCE	20/1	1				2	50/2
SMALL APPLIANCE	20/1	3				4	
DISHWASHER	20/1	5				6	30/2
MAGIC PACK	20/2	7				8	
		9				10	20/1
GENERAL LIGHTING	15/1	11				12	20/1
GENERAL LIGHTING	15/1	13				14	20/1
SPACE		15				16	
TOTAL PHS			0	0	0	CONN. AMPS	0.00
						DEMAND	0.80
TOTAL VA			0			DM. AMPS	0.00

CONTRACTOR SHALL WIRE WIRE ALL INDIVIDUAL UNITS PER THE LATEST EDITION OF THE NATIONAL ELECTRIC CODE. VERIFY THAT THE CONTRACTOR ROUGH-IN, LAYOUT AND UNIT PANEL CIRCUIT BREAKER COUNT MATCH. PROVIDE CIRCUIT BREAKERS IN UNITPANELS PER CODE FOR GENERAL LIGHTING, APPLIANCE LOADS AND SPECIFIC APPLIANCES AND MECHANICAL EQUIPMENT.

PROVIDE AFCI AND DUAL FUNCTION PROTECTIVE DEVICES FOR ALL 120 VOLT, SINGLE PHASE BRANCH CIRCUITS IN ALL ROOMS, EXCEPT FOR BATHROOMS, GARAGES, AND UNFINISHED BASEMENTS PER 2018 IECC. PROVIDE GFI PROTECTIVE OR COMBINATION ARC-FAULT/GFI PROTECTIVE DEVICES WHERE GFI PROTECTION IS NOTED OR REQUIRED BY CODE.

Accord Electric, Inc.
E000127

[Signature]